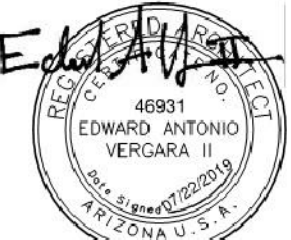


MATERIAL & FINISH SCHEDULE					
MATERIAL DESIGNATION	TYPE	MANUFACTURER & DESCRIPTION	COLOR	SIZE	REMARKS
FLOOR FINISHES					
CPT1	MODULAR CARPET TILE	SHAW: CONTRACT - TRANSPARENT TILE	62505 OXIDE	24" X 24"	INSTALL 1/4 TURN
BBT1	BIO-BASED TILE	ARMSTRONG: STRIATIONS	T3602 STEEL	12" X 24"	BRICK
PT1	PORCELAIN TILE	DALTILE: CITY VIEW 12X24	DOWNTOWN NITE CY04	12" X 24"	BRICK
SCONC	SEALED CONCRETE	MAPEI: EPOXY	09 GRAY		SEE ARCHITECT'S SPECIFICATIONS
FLOOR TRANSITIONS					
	CARPET TILE AND VCT OR VAT	ROPPE RUBBER TRANSITION	100 BLACK		
	CARPET TILE AND PORCELAIN TILE	SCHLUTER SCHIENE	SATIN ALUMINUM ANODIZED		MAY NEED TO USE ROPPE SUBFLOOR LEVELER IN ADDITION TO SCHLUTER TRIM TO BRING HEIGHT OF CARPET TILE TO HEIGHT OF PORCELAIN TILE
	CARPET TILE AND CONCRETE	ROPPE RUBBER EDGE GUARD	100 BLACK		
	PORCELAIN TILE AND VCT OR VAT	SCHLUTER RENO-U	SATIN ALUMINUM ANODIZED		
	PORCELAIN TILE AND CONCRETE	SCHLUTER RENO-V	SATIN ALUMINUM ANODIZED		BACKFILL ADJUSTABLE ARM W/ MORTAR
	VCT AND CONCRETE	ROPPE RUBBER REDUCER	100 BLACK		
	VCT AND VAT				SCRIBE NEW VCT TO EXISTING VAT
WALL BASE					
RB1	RUBBER COVE BASE	ROPPE	100 BLACK	4" HIGH	
PTB1	PORCELAIN TILE	DALTILE: CITY VIEW 12X24	DOWNTOWN NITE CY04	12" X 12"	FIELD CUT TO 4"H x 12" W, INSTALL HORIZONTALLY. ALIGN GROUT JOINTS, DO NOT STAGGER
PTB2	GROUT PORCELAIN TILE GROUT	MAPEI: EPOXY DALTILE: CITY VIEW: COVE BASE S-36C9T MAPEI: EPOXY	09 GRAY SKYLINE GRAY CY02 02 PEWTER	6" X 12"	
WALL FINISHES					
PWT1	PORCELAIN WALL TILE GROUT	DALTILE: CITY VIEW MAPEI: EPOXY	SKYLINE GRAY CY02 02 PEWTER	6" X 12"	INSTALL IN 1/2 RUNNING BOND PATTERN
PWT2	PORCELAIN WALL TILE TRIM GROUT	DALTILE: CITY VIEW: BULLNOSE S-43C9 MAPEI: EPOXY	SKYLINE GRAY CY02 02 PEWTER	3" X 12"	
PWT3	PORCELAIN MOSAIC GROUT	DALTILE: SLATE RADIANCE 1X1 MOSAIC (4" STRIPS) MAPEI: EPOXY	SA55 FLINT 02 PEWTER	12" X 12"	INSTALL 4" X 12" - SEE ELEVATIONS
P1	PAINT	DUNN EDWARDS: SUPREMA: EGGSHELL FINISH	DE6232 ABSTRACT WHITE		FIELD PAINT COLOR
P2	PAINT	DUNN EDWARDS: SUPREMA: EGGSHELL FINISH	DE6363 POINTED ROCK		ACCENT
P3	PAINT	DUNN EDWARDS: SUPREMA: EGGSHELL FINISH	DE5179 BRONZE ORANGE		ACCENT
P4	PAINT	DUNN EDWARDS: SUPREMA: EGGSHELL FINISH	DE6361 BABY SEAL		ACCENT: CONFERENCE, HUDDLE, SOFFITS
P5	PAINT	DUNN EDWARDS: SUPREMA: EGGSHELL FINISH	DE5972 LAKEVILLE		ACCENT: OFFICES
P6	PAINT	DUNN EDWARDS: SUPREMA: EGGSHELL FINISH	DE5536 DILL GRASS		ACCENT: OFFICES
P7	PAINT	DUNN EDWARDS: PERMASHEEN ENAMEL: SEMI-GLOSS FINISH	DE6363 POINTED ROCK		DOOR FRAMES/ELEVATORS
P1E	PAINT	DUNN EDWARDS: PERMASHEEN ENAMEL: SEMI-GLOSS FINISH	DE6232 ABSTRACT WHITE		FIELD PAINT COLOR: BATHROOMS/BREAK RM/LAC/JAN
P2E	PAINT	DUNN EDWARDS: PERMASHEEN ENAMEL: SEMI-GLOSS FINISH	DE6363 POINTED ROCK		ACCENT COLOR: BREAK RM
P3E	PAINT	DUNN EDWARDS: PERMASHEEN ENAMEL: SEMI-GLOSS FINISH	DE5179 BRONZE ORANGE		ACCENT COLOR: BREAK RM
P8	PAINT	DUNN EDWARDS: SUPREMA: FLAT FINISH	DEA187 BLACK		EXPOSED STRUCT @ CLOUD & BLADE AREAS - ABOVE 10' A.F.F.
WC1	WALL PANEL	ACROVYN: BEVEL EDGE WALL PANELS: STIPPLE TEXTURE	101 FRENCH CREAM	48" X 48"	INSTALL 48" H X 48" W PANEL APPLIED TO GWB ON WALLS BEHIND MOP SINK
CEILING FINISHES					
ACT1	ACOUSTICAL CEILING TILE GRID	ARMSTRONG: CIRRUS SECOND LOOK II: 24" X 24" TEGULAR (2X4) ARMSTRONG: PRELUDE: 15/16" EXPOSED TEE GRID	(WH) WHITE WHITE		24" X 48" GRID
ACT2	ACOUSTICAL CEILING TILE GRID	ARMSTRONG: CIRRUS SECOND LOOK II: 24" X 24" TEGULAR (2X2) ARMSTRONG: PRELUDE: 15/16" EXPOSED TEE GRID	(WH) WHITE WHITE		24" X 24" GRID
ACS1	ACOUSTICAL CEILING SOUNDSCAPES GRID	ARMSTRONG: SOUNDSCAPES: SQUARE CONCAVE/CONVEX ARMSTRONG: DECK HANGING KITS	(WH) WHITE WHITE		
ACS2	ACOUSTICAL CEILING SOUNDSCAPES GRID	ARMSTRONG: SOUNDSCAPES: BLADES 7190 ARMSTRONG: DECK HANGING KITS	(WH) WHITE WHITE		
HORIZONTAL & VERTICAL SURFACES (MILLWORK)					
PLAM1	PLASTIC LAMINATE	WILSONART	7909-60 FUSION MAPLE		BREAK RM/WORK AREA: CABINETS - SEE MILLWORK
SS1	SOLID SURFACE	CORIAN	MATTERHORN		RESTROOMS: COUNTERTOP @ SINK RECEPTION WINDOW & WINDOW SILLS & BREAK ROOM / WORK AREA COUNTERTOPS
SS2	SOLID SURFACE	WILSONART	1572SL (1) ANTIQUE WHITE		
WINDOW COVERINGS					
RS1	ROLLER SHADES	HUNTER DOUGLAS: SHEERWEAVE 1% OPENNESS	WHITE/LINEN		INSIDE ROLL W/ STAINLESS STEEL CHAIN
RS2	ROLLER SHADES	HUNTER DOUGLAS: SHEERWEAVE 3% OPENNESS	WHITE/LINEN		INSIDE ROLL W/ STAINLESS STEEL CHAIN
NOTE: FINAL COLOR SELECTIONS TO BE CONFIRMED IN A SUBMITTAL AND APPROVED BY PIMA COUNTY					


PIMA COUNTY FACILITIES MANAGEMENT, 150 WEST CONGRESS, TUCSON ARIZONA 85701 (520)740-3085

ADMIN WEST FIFTH FLOOR TI
ROOM FINISH SCHEDULE

ADMINISTRATION WEST BUILDING
150 WEST CONGRESS
TUCSON, AZ

SEAL

REVISED:  DATE:

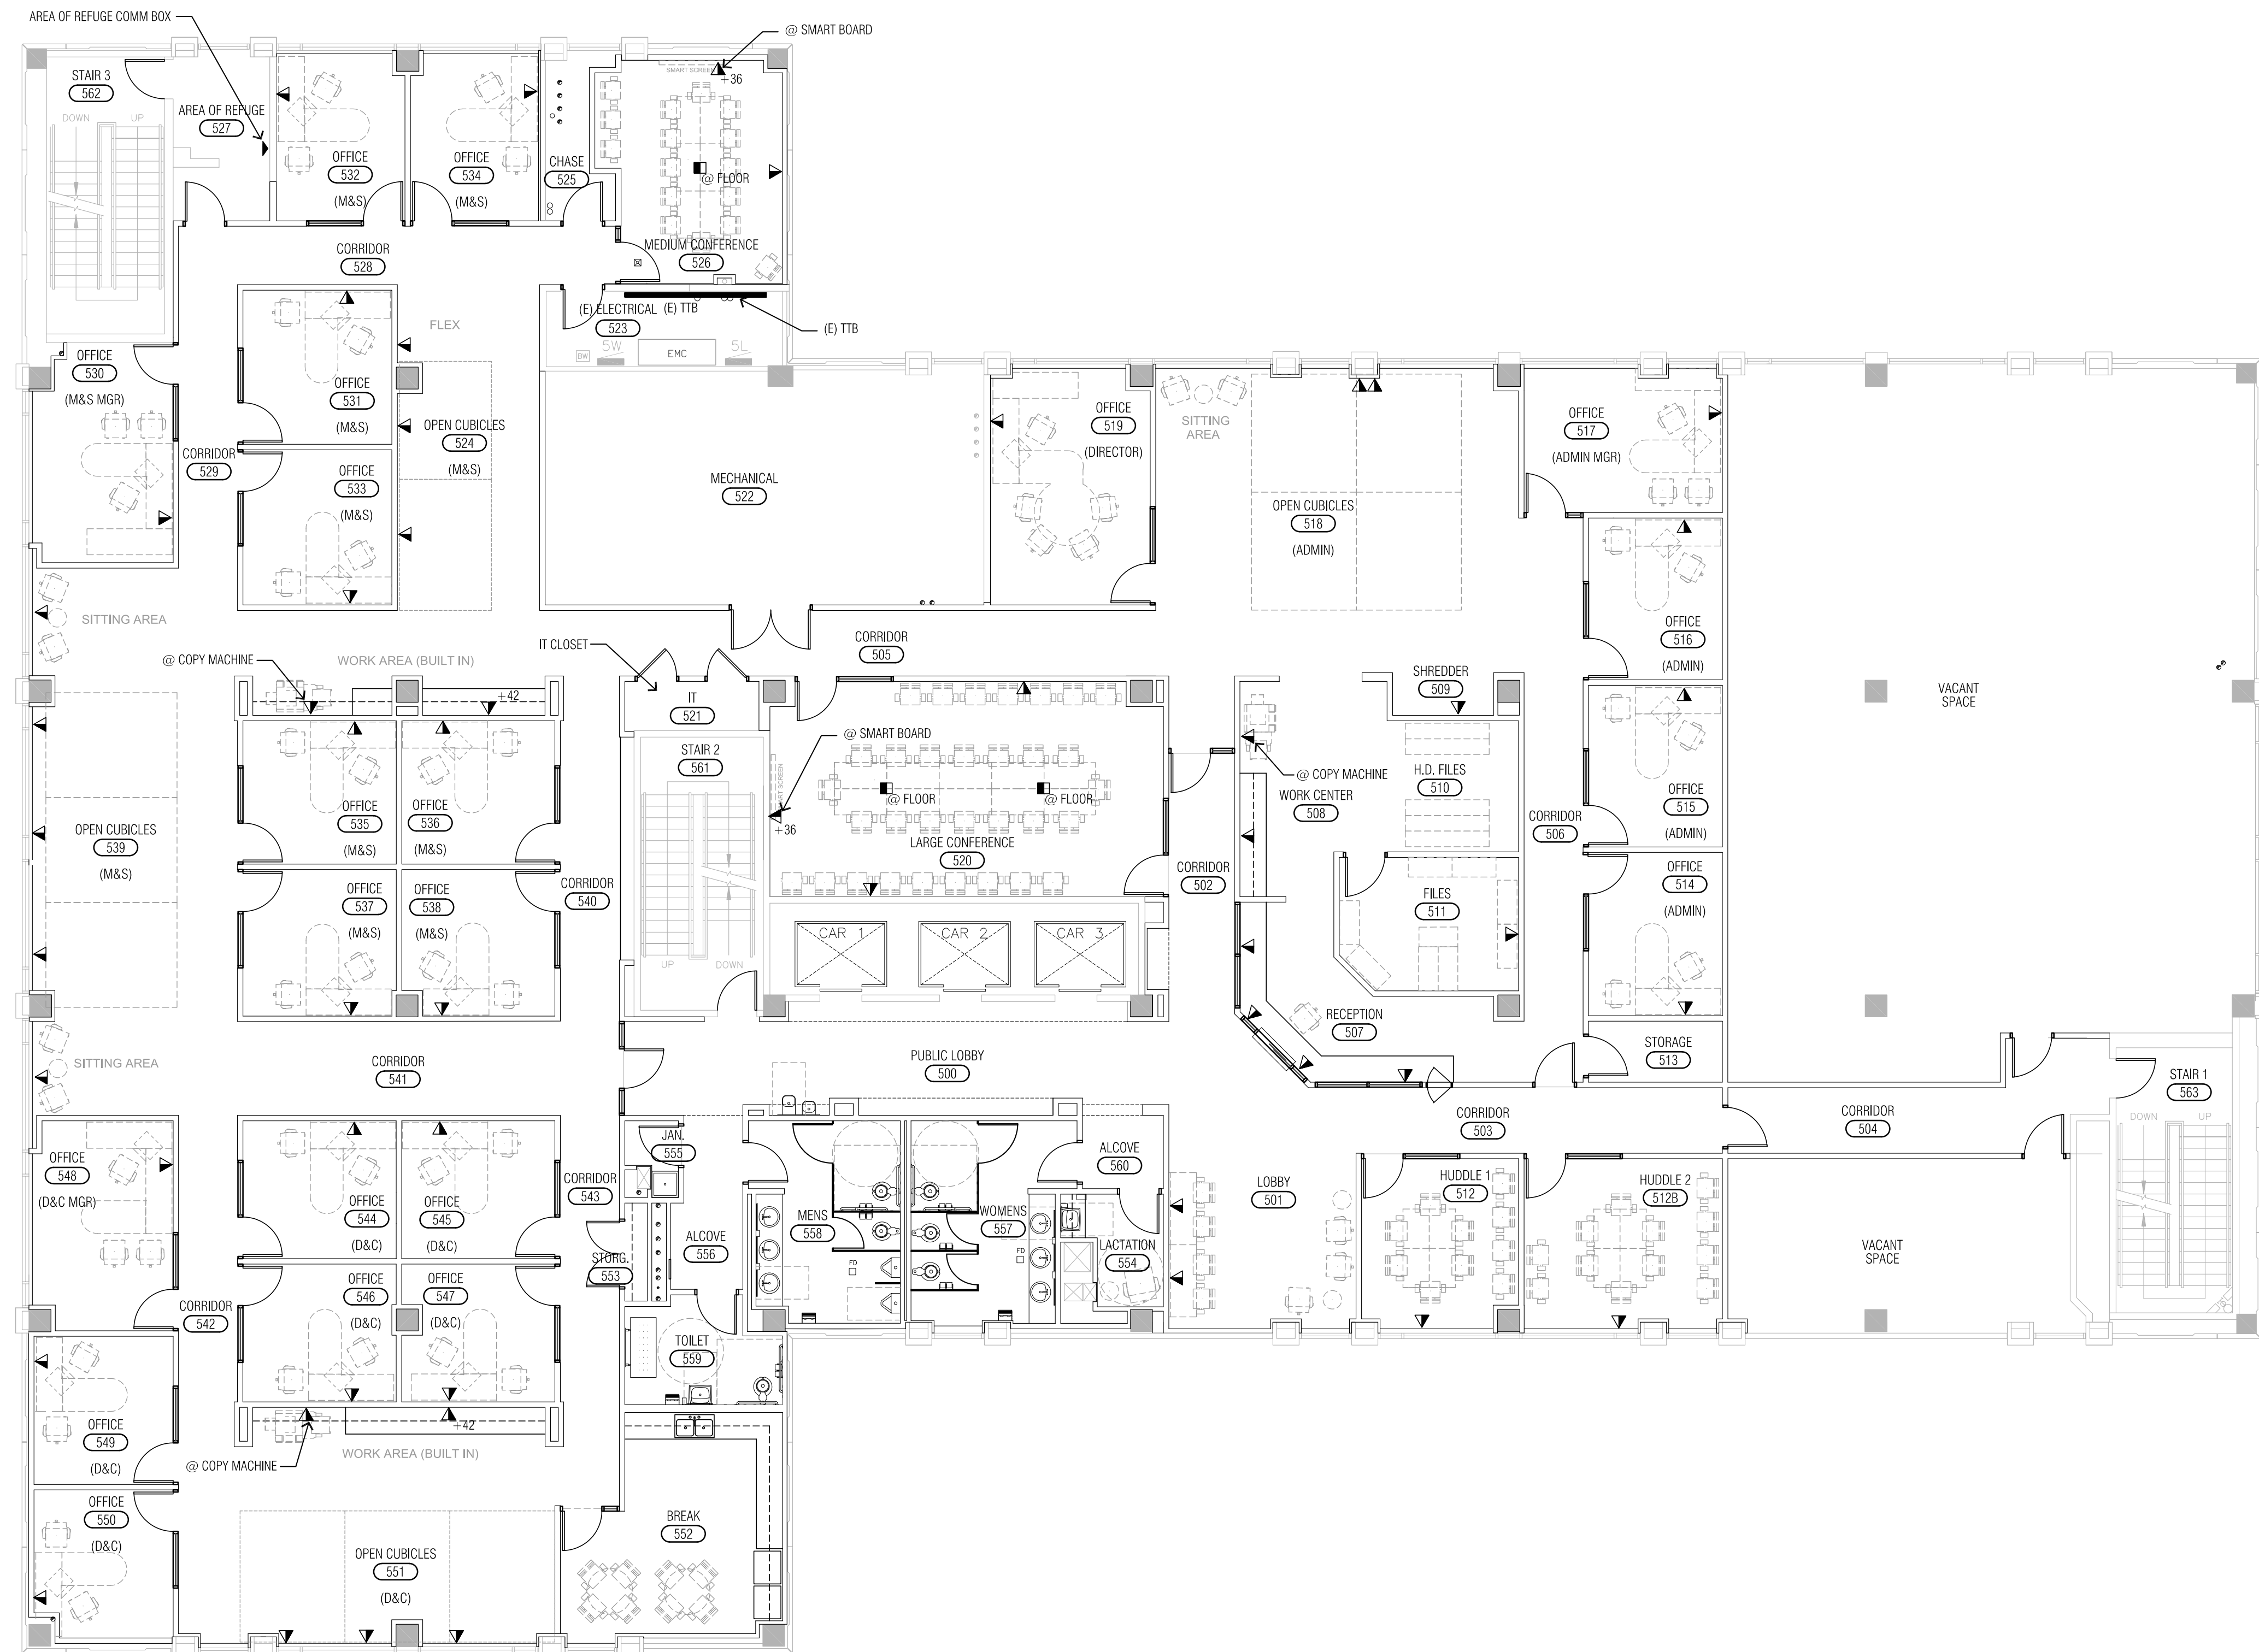DRWN BY: **SS**
CKD BY: **EAV**
DATE: **07/22/19**
SCALE: **AS NOTED**
SHEET NO:
A5.1
15 OF 48
W.O. NUMBER
19*10427



- LEGEND:
- TTB (E) TELEPHONE TERMINAL BACKBOARD
 - ▲ WALL MOUNTED TELECOM OUTLET @ 18" A.F.F.
 - ▲+36 WALL MOUNTED TELECOM OUTLET @ 36" A.F.F.
 - ▲+42 WALL MOUNTED TELECOM OUTLET @ 42" A.F.F.
 - IN FLOOR TELECOM OUTLET
 - AREA OF REFUGE COMMUNICATION SYSTEM (PROVIDE COMM LINE)
- NOTES:
1. DEVICE MOUNTING HEIGHTS ARE SHOWN FOR REFERENCE ONLY. COORDINATE FINAL LOCATION AND HEIGHT WITH ARCHITECTURAL, ELECTRICAL, ELEVATIONS AND MILLWORK DRAWINGS.
 2. NETWORK CABLE TO BE CAT 6A XTP. REFER TO SPECIFICATIONS FOR ADDITIONAL INFORMATION.

1 TELECOM PLAN

Scale: 1/8" = 1'-0"

FURNITURE SHOWN
FOR REFERENCE ONLY

PIMA COUNTY FACILITIES MANAGEMENT, 150 WEST CONGRESS, TUCSON ARIZONA 85701 (520)740-3085

ADMIN WEST FIFTH FLOOR TI
TELECOM PLAN

ADMINISTRATION WEST BUILDING
150 WEST CONGRESS
TUCSON, AZ

SEAL

46981
EDUARDO ANTONIO
VERGARA II
REGISTERED PROFESSIONAL
ELECTRICAL ENGINEER
ARIZONA

SEAL of PIMA COUNTY
ARIZONA

REV: DATE:

DRWN BY: SS
CKD BY: EAV
DATE: 07/22/19
SCALE: AS NOTED
SHEET NO:

TC1.0
16 OF 48
W.O. NUMBER
19*10427